



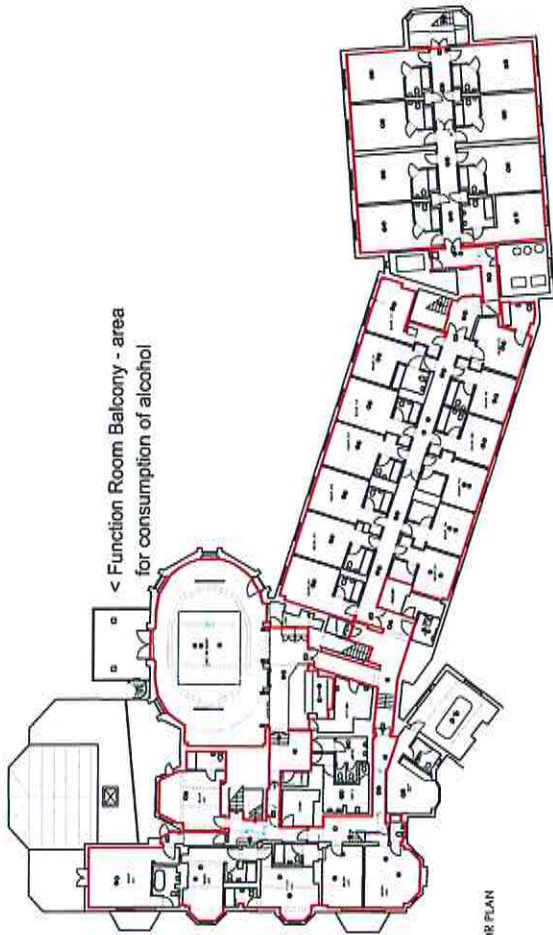

PROPOSED FIRST FLOOR PLAN
SCALE 1:200

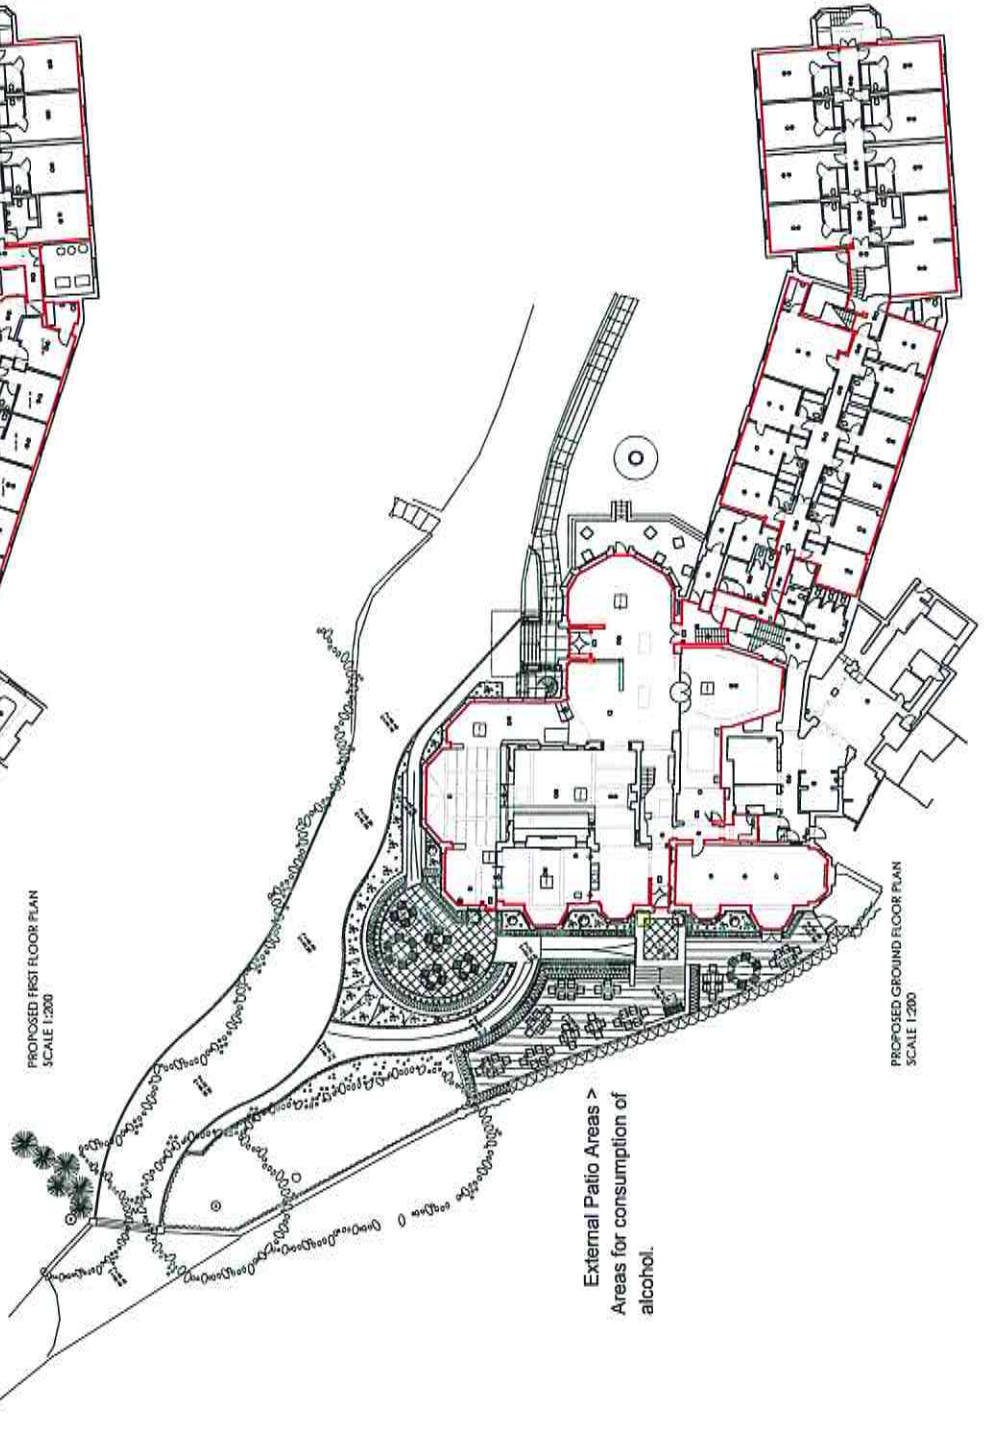

PROPOSED GROUND FLOOR PLAN
SCALE 1:200

< Function Room Balcony - area
for consumption of alcohol

External Patio Areas >
Areas for consumption of
alcohol.

EXIT SIGNS

Exit signs shall be provided in accordance with BS 5446 Part 1.

FIRE ALARM SYSTEM

The fire alarm system shall be provided in accordance with BS 5839-1:2002. The system shall be designed to provide early warning of fire and to enable the occupants to evacuate the building safely.

EMERGENCY LIGHTING

Emergency lighting shall be provided in accordance with BS 5266-1:2009. The system shall be designed to provide illumination in the event of a power failure.

OF INTERNAL LICENSED AREA
= 1000 APPROX 100 m²

IF INTERNAL LICENSED AREA
= 1000 APPROX 100 m²

EMERGENCY LIGHTING

Emergency lighting shall be provided in accordance with BS 5266-1:2009. The system shall be designed to provide illumination in the event of a power failure.

Emergency lighting shall be provided in accordance with BS 5266-1:2009. The system shall be designed to provide illumination in the event of a power failure.

PROPOSED



T: 01825 802088 F: 01825 802088

Level House - Birmingham - Cheshire - Bedfordshire

Office - Birmingham - Cheshire - Bedfordshire

Project - Birmingham - Cheshire - Bedfordshire

Client - Birmingham - Cheshire - Bedfordshire

Quantity - 1000 - 1000 - 1000

Drawings - 1000 - 1000 - 1000